
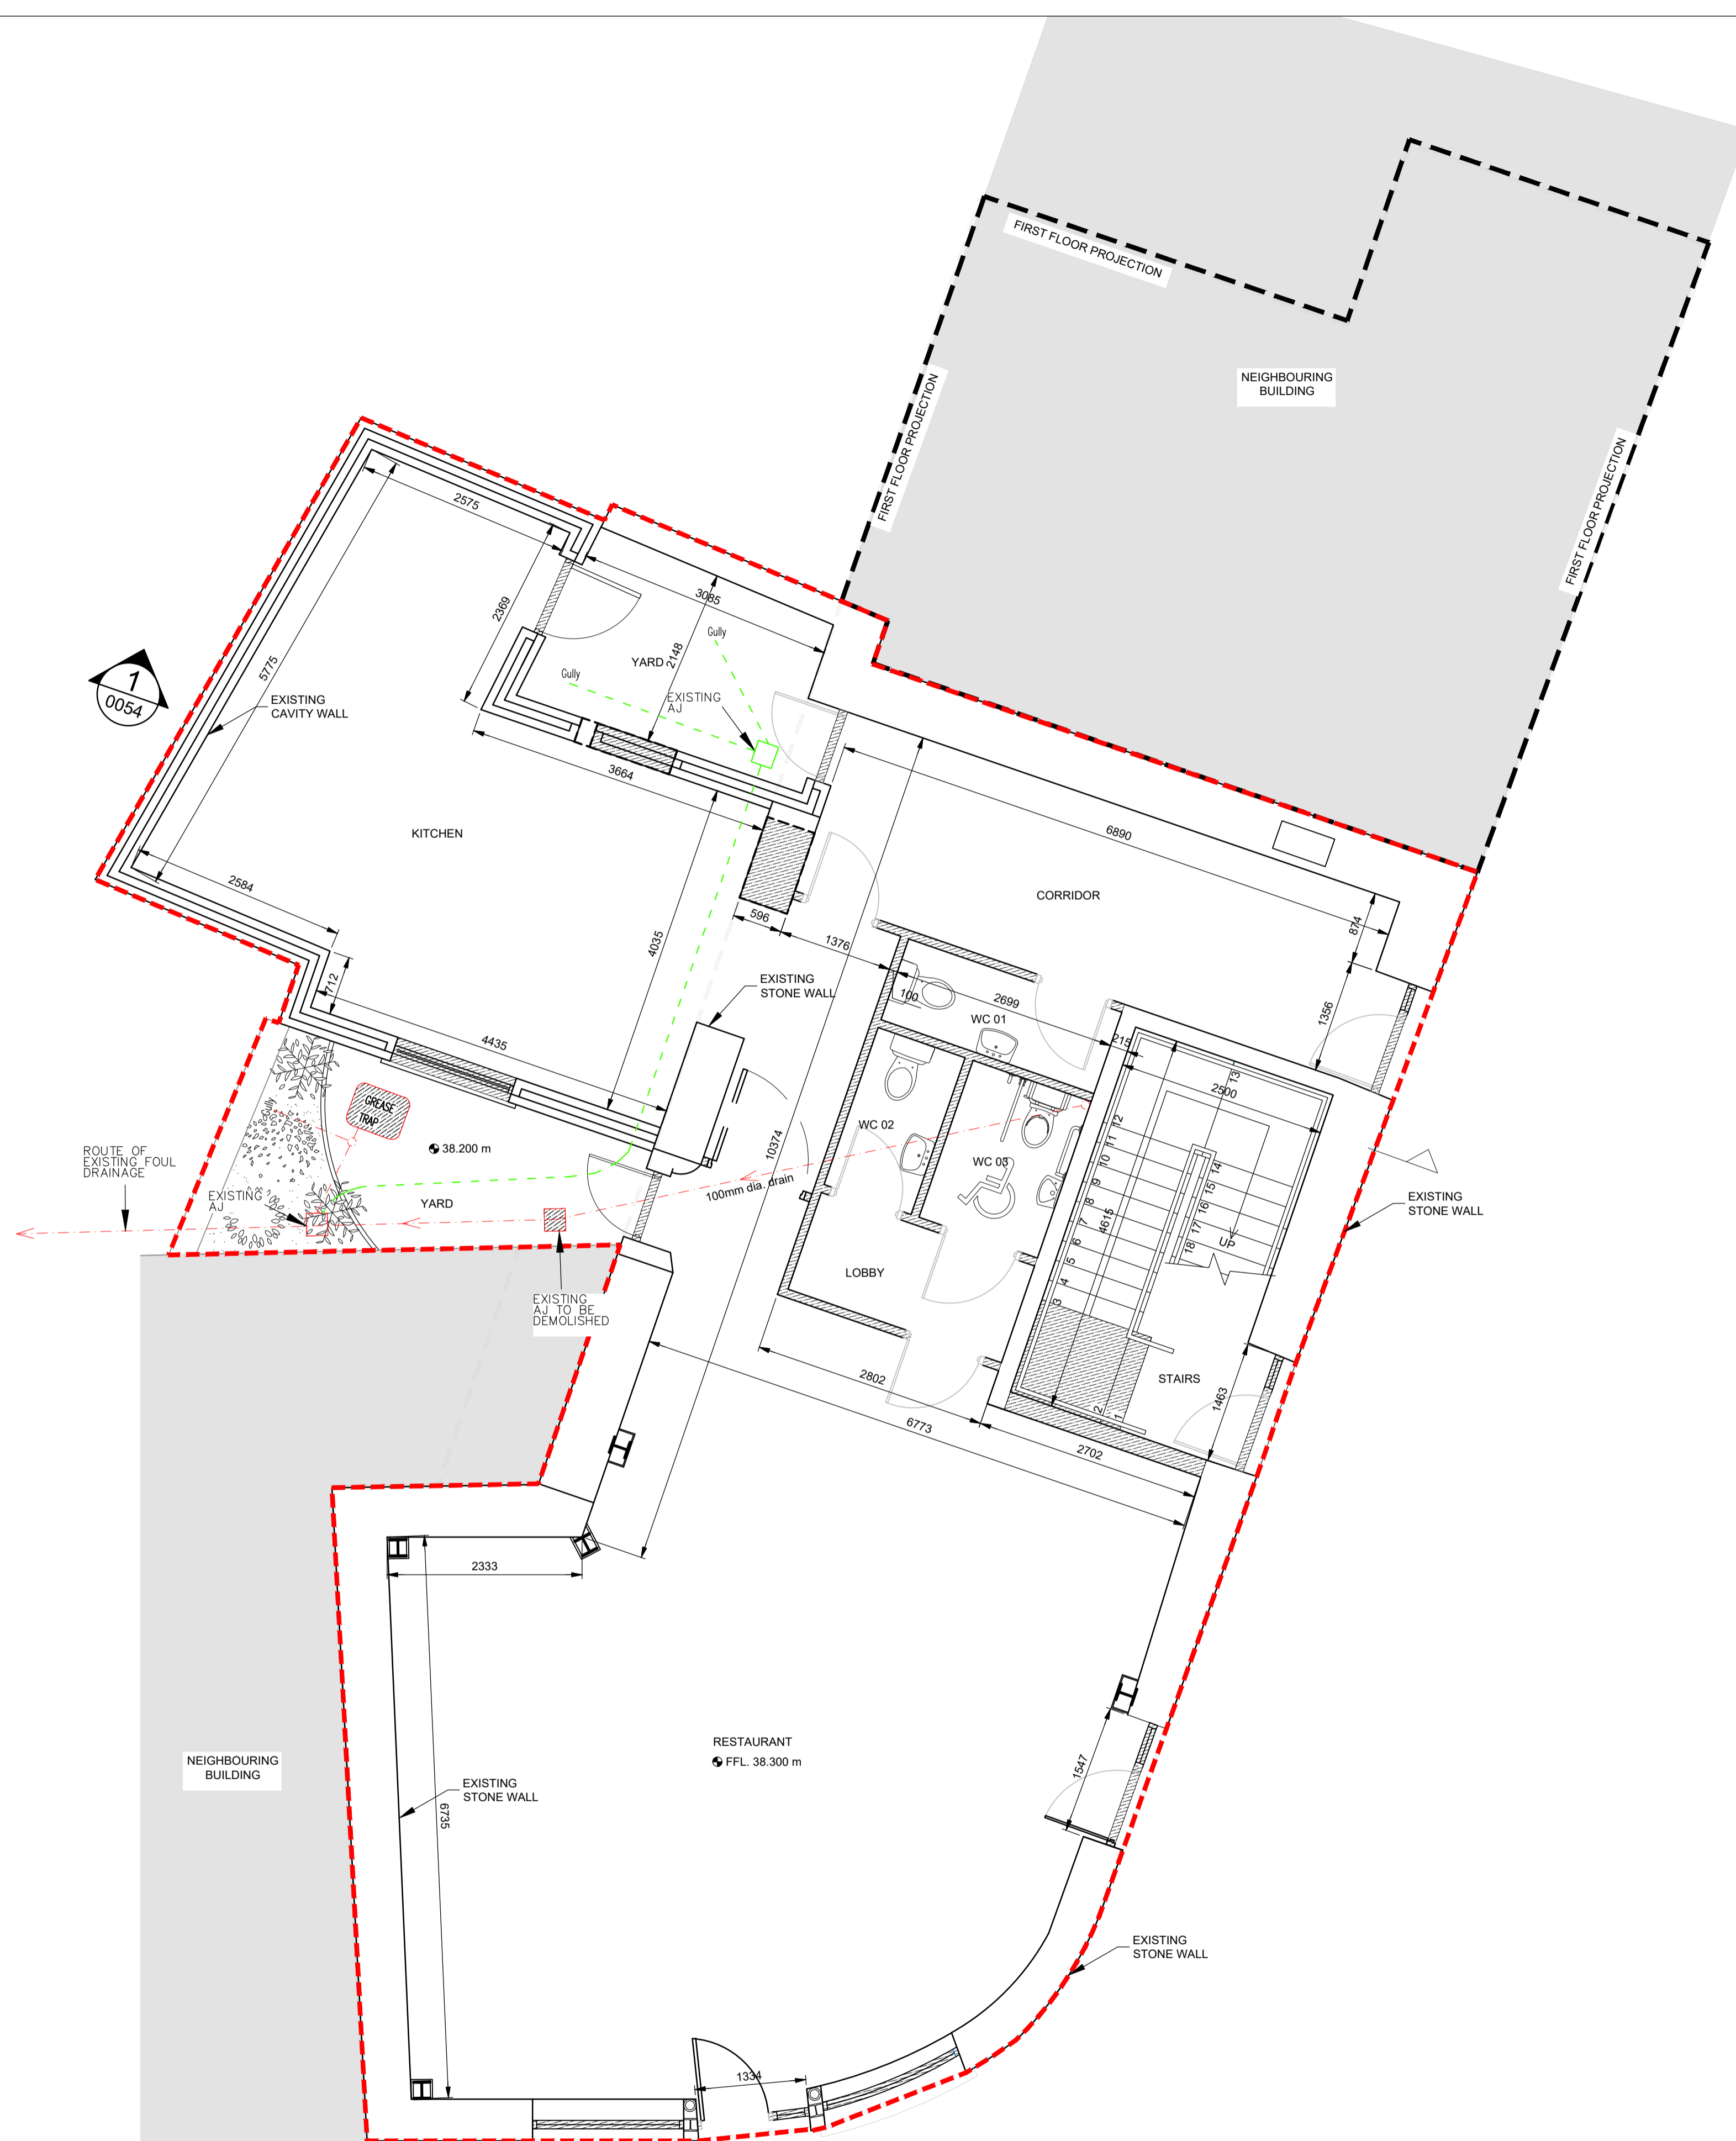


GENERAL NOTES

- ALL DIMENSIONS ARE IN MILLIMETERS.
- ALL LEVELS ARE IN METERS AND REFER TO ORDNANCE DATUM MALIN HEAD.
- WORKING DIMENSIONS SHOULD NOT BE SCALED FROM DRAWINGS. USE WRITTEN DIMENSIONS ONLY.
- VERIFY ALL DIMENSIONS ON SITE BEFORE WORK COMMENCES.
- THIS DRAWING IS NOT FOR CONSTRUCTION PURPOSES UNLESS SPECIFICALLY STATED.
- ALL CONTRACTORS AND SUB CONTRACTORS ARE RESPONSIBLE FOR ENSURING THEIR COMPLIANCE WITH CURRENT BUILDING REGULATIONS & CODES OF PRACTICE.
- DISCREPANCIES SHALL BE BROUGHT TO THE ATTENTION OF THE CONSULTANTS.
- ALL WORKS TO BE CARRIED OUT IN COMPLIANCE WITH HEALTH & SAFETY GUIDELINES & LEGISLATION.
- IF IN DOUBT ASK. ©

LEGEND OF SYMBOLS

----- PROPOSED SITE BOUNDARY OUTLINED THUS

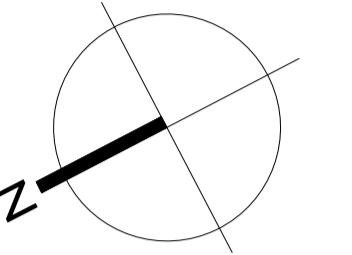

REV.	DESCRIPTION.	DATE.	BY.

**Notes:**  
Do not scale from drawings.  
All discrepancies to be reported immediately.  
All dimensions to be verified by contractor on site prior to any works.

PROJECT: Proposed Development at Burkes Lane, Athenry  
DRAWING TITLE: Existing Drainage

Source: Regeneration Office, Department of Enterprise Rural & Community Development, Galway County Council



Address:  
Regeneration Office,  
Dept of Enterprise Rural & Community  
Development,  
Galway County Council, Áras an Chontae,  
Prospect Hill, Galway.  
TEL NO: +353(0)91 509000

DWG NO: ATH-GCC-XX-00-DR-A-010	
REF: 010-existing drainage layout	
REV	SCALE 1:50
JOB NO	DATE 06.03.23
SIZE A1	STATUS Part 8
DRW BY	CKD BY J.P.O'C.