


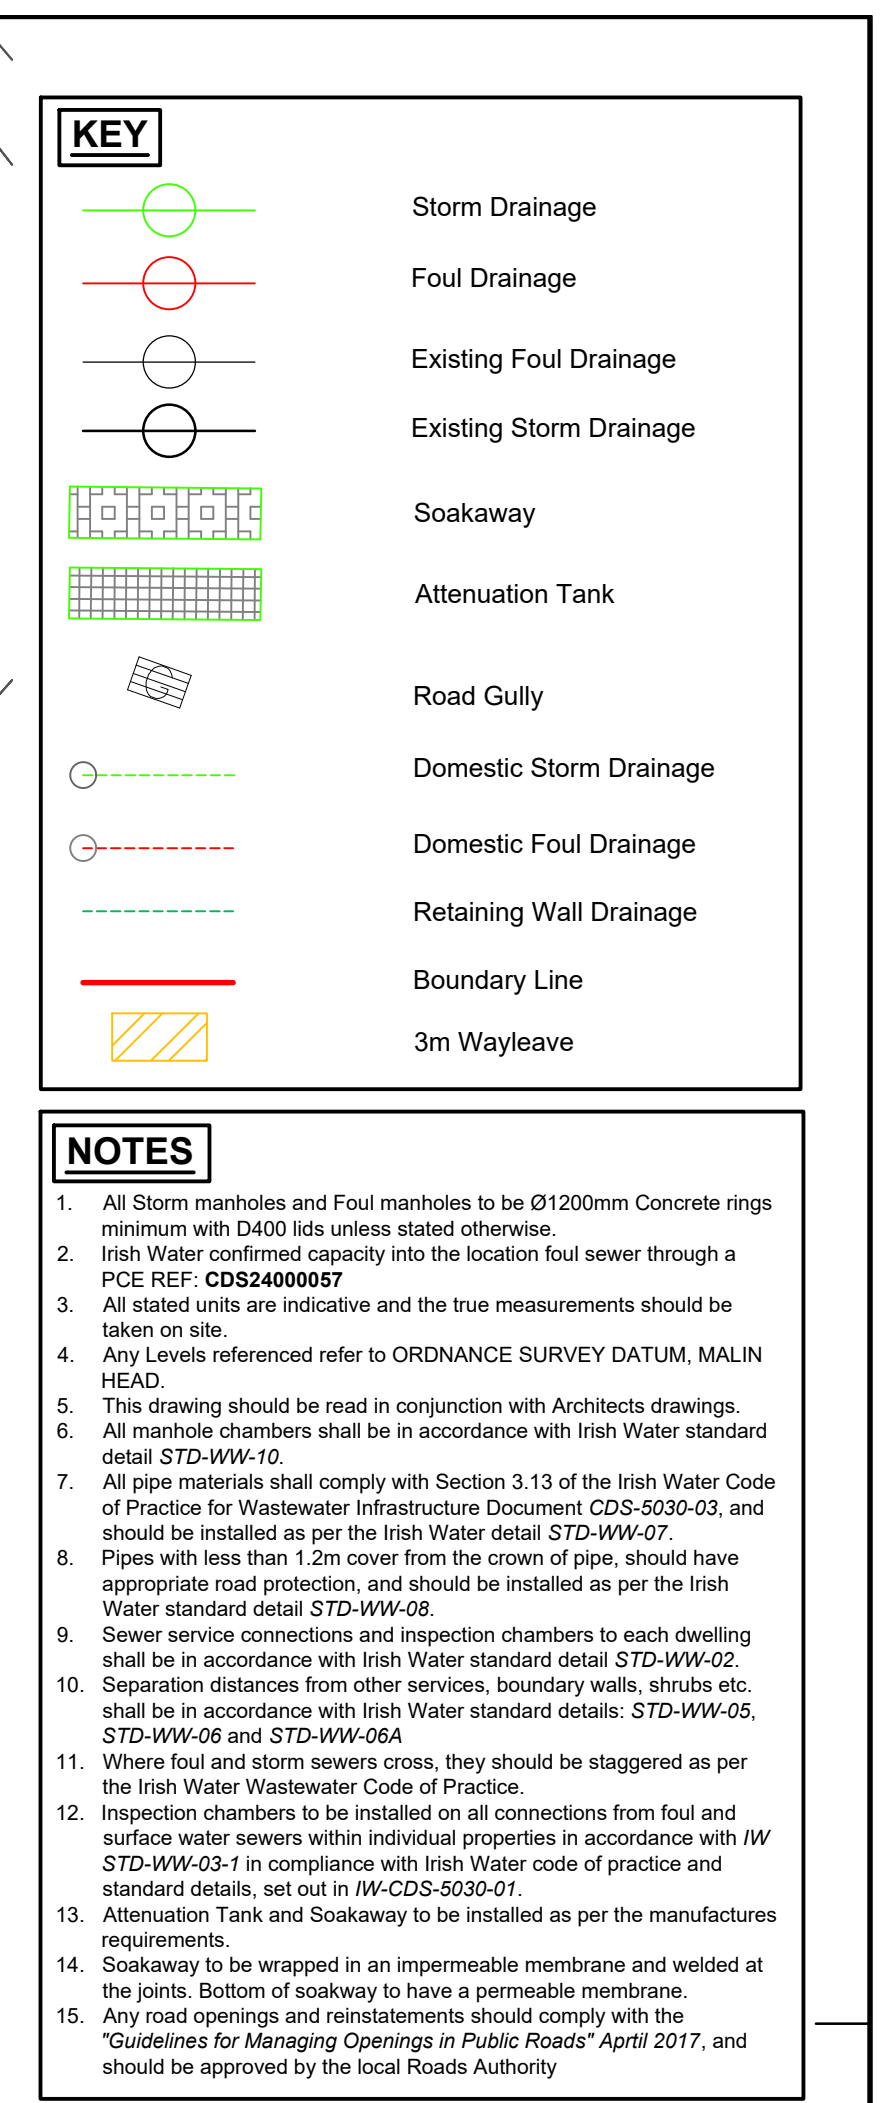

Reference	Diameter(mm)	Cover Level	Invert Level	DS Reference	Pipe Diameter(mm)	Pipe Gradient(1:x)	Pipe Length(m)	Depth(m)
S1	1200	42.820	41.000	S2	150	36	27.155	1.82
S2	1800	41.897	40.246	S3	225	65	33.542	1.65
S3	1200	41.260	39.727	S4	225	61	4.667	1.53
S4	2100	41.140	39.330	SW	450	397	15.868	1.75
SW	-	41.400	39.000	-	-	-	-	2.40
S6	1200	40.760	39.200	S7	150	75	22.740	1.56
S7	1200	40.313	38.898	S8	150	51	10.141	1.42
S8	1200	40.110	37.700	S9	225	74	11.147	2.41
S9	1200	39.820	37.550	S10	225	93	18.574	2.27
S10	1200	39.520	37.350	S11	225	65	32.308	2.17
S11	1200	38.820	36.850	Tank	225	64	6.408	1.97
Tank	1200	38.700	36.750	S12	225	102	6.130	1.95
S12	1200	38.600	36.690	EXSMH	225	92	9.177	1.91
S2-2	1200	43.700	42.100	S2-1	150	40	16.884	1.60
S2-1	1200	43.060	41.678	S2	150	32	45.462	1.38
S5-3	1200	42.280	40.600	S5-2	150	50	36.484	1.68
S5-1	1200	41.120	40.000	S5-2	150	65	8.507	1.12
S5-2	1500	41.310	39.870	S5	225	130	50.096	1.44
S5	1800	40.839	39.485	S4	300	134	12.739	1.35
S9-1	1200	40.000	38.650	S9	150	101	49.129	1.35

P.01	RF	XX/XX/24	FIRST ISSUE
REV	BY	DD/MM/YY	DESCRIPTION
Client:  Comhairle Chontae na Gaillimhe Galway County Council			
Project: Farranamartin Housing Development, Tuam, Galway			
Stage: Planning			
Drawing title: Drainage Layout			
Scale: 1:500		Size: A1	
Drawn by: CB	Checked: CT	Architect: Collins-Rolston	Date: 04/12/24
Gilligan CONSULTING CIVIL & STRUCTURAL ENGINEERS 23 BEDFORD STREET, BELFAST, BT27EJ TELEPHONE: 028 9023 2841 FACSIMILE: 028 9024 7104			
Drawing No: 2456-D-GNI-XX-ZZ-DR-C-0001			Revision: P